


寄件者:
寄件日期: 2024年04月16日星期二 16:11
收件者: tpbpd/PLAND
副本: Pak Him CHIU/PLAND; Ryan Long Yin CHAN/PLAND; Allgain Hk
主旨: 有關A/YL-MP/361消防處意見回覆
附件: MP361_FSplan_20240415.pdf; MP361_Plan_20240415.pdf
類別: Internet Email

敬啟者，

有關 A/YL-MP/361 消防處意見回覆請參照附件。


如有任何查詢，可直接與本人聯絡。

黃先生
電話：

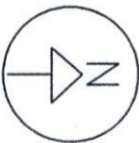


Legend:

- ⊗ 4kg dry powder type fire extinguisher
- ⊙ 9 Litre water type fire extinguisher
- ⊙ 5kg co2 type fire extinguisher
- S.B SAND BUCKET
- Lot Boundary
- New installations

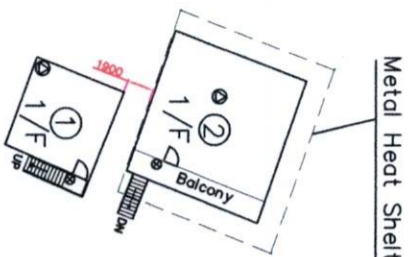

F.S. LAYOUT PLAN OF 1/F

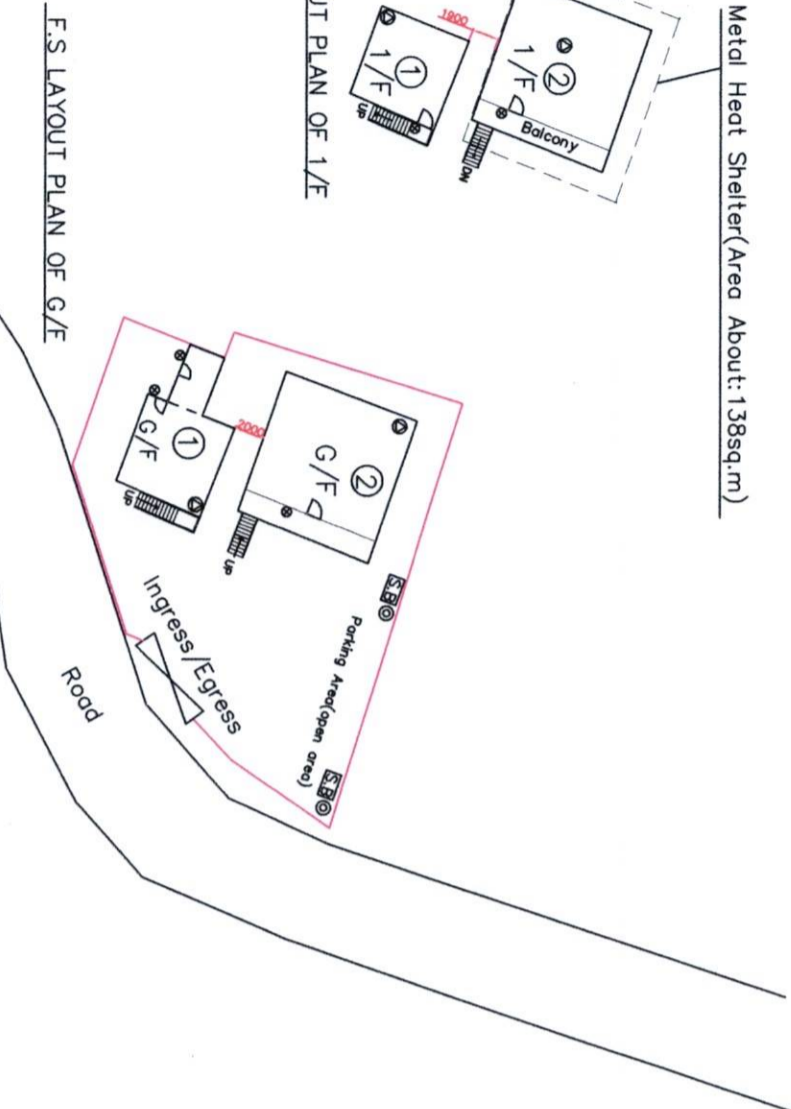

F.S. LAYOUT PLAN OF G/F

NATURE OF OCCUPANCY:

- ① 2-Storey structure for shop (GFA: Not exceeding 91.5 sq.m, Height: Not exceeding 5.5m)
- ② 2-Storey structure for shop and office (GFA: Not exceeding 183.5 sq.m, Height: Not exceeding 7.5m) under the Metal Heat Shelter (Area About 138sq.m).
 - G/F of structure for shop.
 - 1/F of structure for office.

Fire Notes:

- 1. Sufficient emergency lighting shall be provided throughout the entire building in accordance with BSS5266-1:2016, BS EN 1838:2013 and the FSD Circular Letter No.4/2021.
- 2. Sufficient directional and exit sign shall be provided in accordance with BS 5266:Part 1 and FSD Circular letter 5/2008.
- 3. Sufficient portable hand-operated approved appliance shall be provided as required by occupancy and as marked on plans.

**INTERCEPT FIRE & SECURITY
TECHNICIANS LIMITED**

Registered Address:
Shop 25 & 84, G/F, Man Fung Building, Y.L.T.329 Fung Kwon Street,
Yuen Long, N.T.
Tel: 92637766, Fax: 24285932
Business Address:
8/F, Block L, Phase 2, Man Fung Industrial Centre, 33-39 Kwai Fung
Street, Kwai Chung, N.T.
Tel: 24255404, Fax: 24285932

Project:

Proposed Temporary Shop and Services for
for A Period of 3 years at Lots 3250 S.B.
ss.48 and 3250 S.B. ss 49 (Part) in D.D 104
and Adjoining Government Land, Mai Po,
Yuen Long.

Title:

Proposed Fire Service
Installation Layout Plan

Drawn by: W.C. WONG

Date: 2024-04-15

Scale: 1:500 @ A3

Ref No: TPB/A/YL-MP/361

Drawing No: 2024/FS/007

N


Structure 2 (Existing)

Shop

GFA: Not exceeding 183.5m²

No. of storey: 2

Height: Not exceeding 7.5m

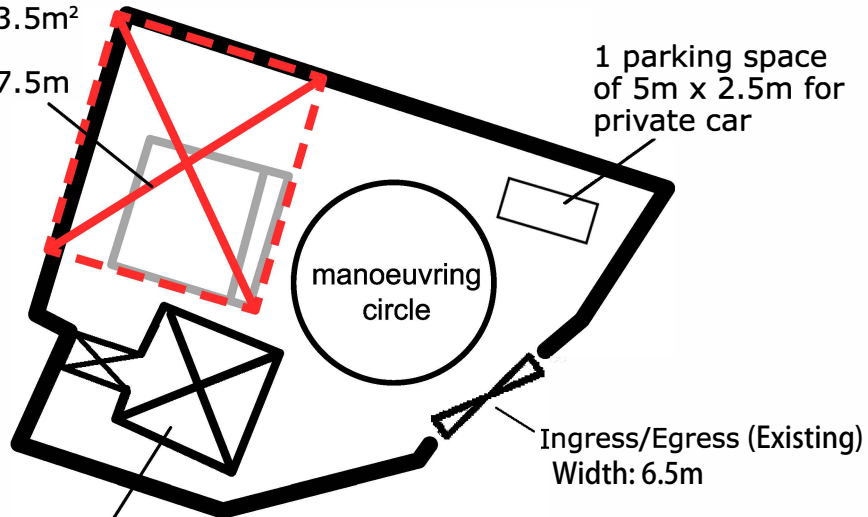

Structure 1 (Existing)

Shop

GFA: Not exceeding 91.5m²

No. of Storey: 2

Height: Not exceeding 5.5m

Project 項目名稱 :

Proposed Temporary Shop and Services for a Period of 3 Years at Lots 3250 S.B ss.48,3250 S.B ss.49(part) in D.D.104 and Adjoining Government Land, MaiPo, YuenLong, N.T.

Drawing Title 圖紙標題 :

Layout Plan



Drawing No. 圖號:

20240415

Remarks 備註 :



Metal Heat Shelter

Scale 比例 :